



**Air Source Heat Pump Location**  
 To be determined by size of external unit required.  
 First Choice location either ground or wall mounted.  
 Second Choice location ground mounted and surrounded by protective screening.

**Rainwater Header tank required for gravity feed to WCs and Pond**  
 To be fully insulated.

**Solar panels**  
 There will be solar panels located across the roof to allow for electricity generation.

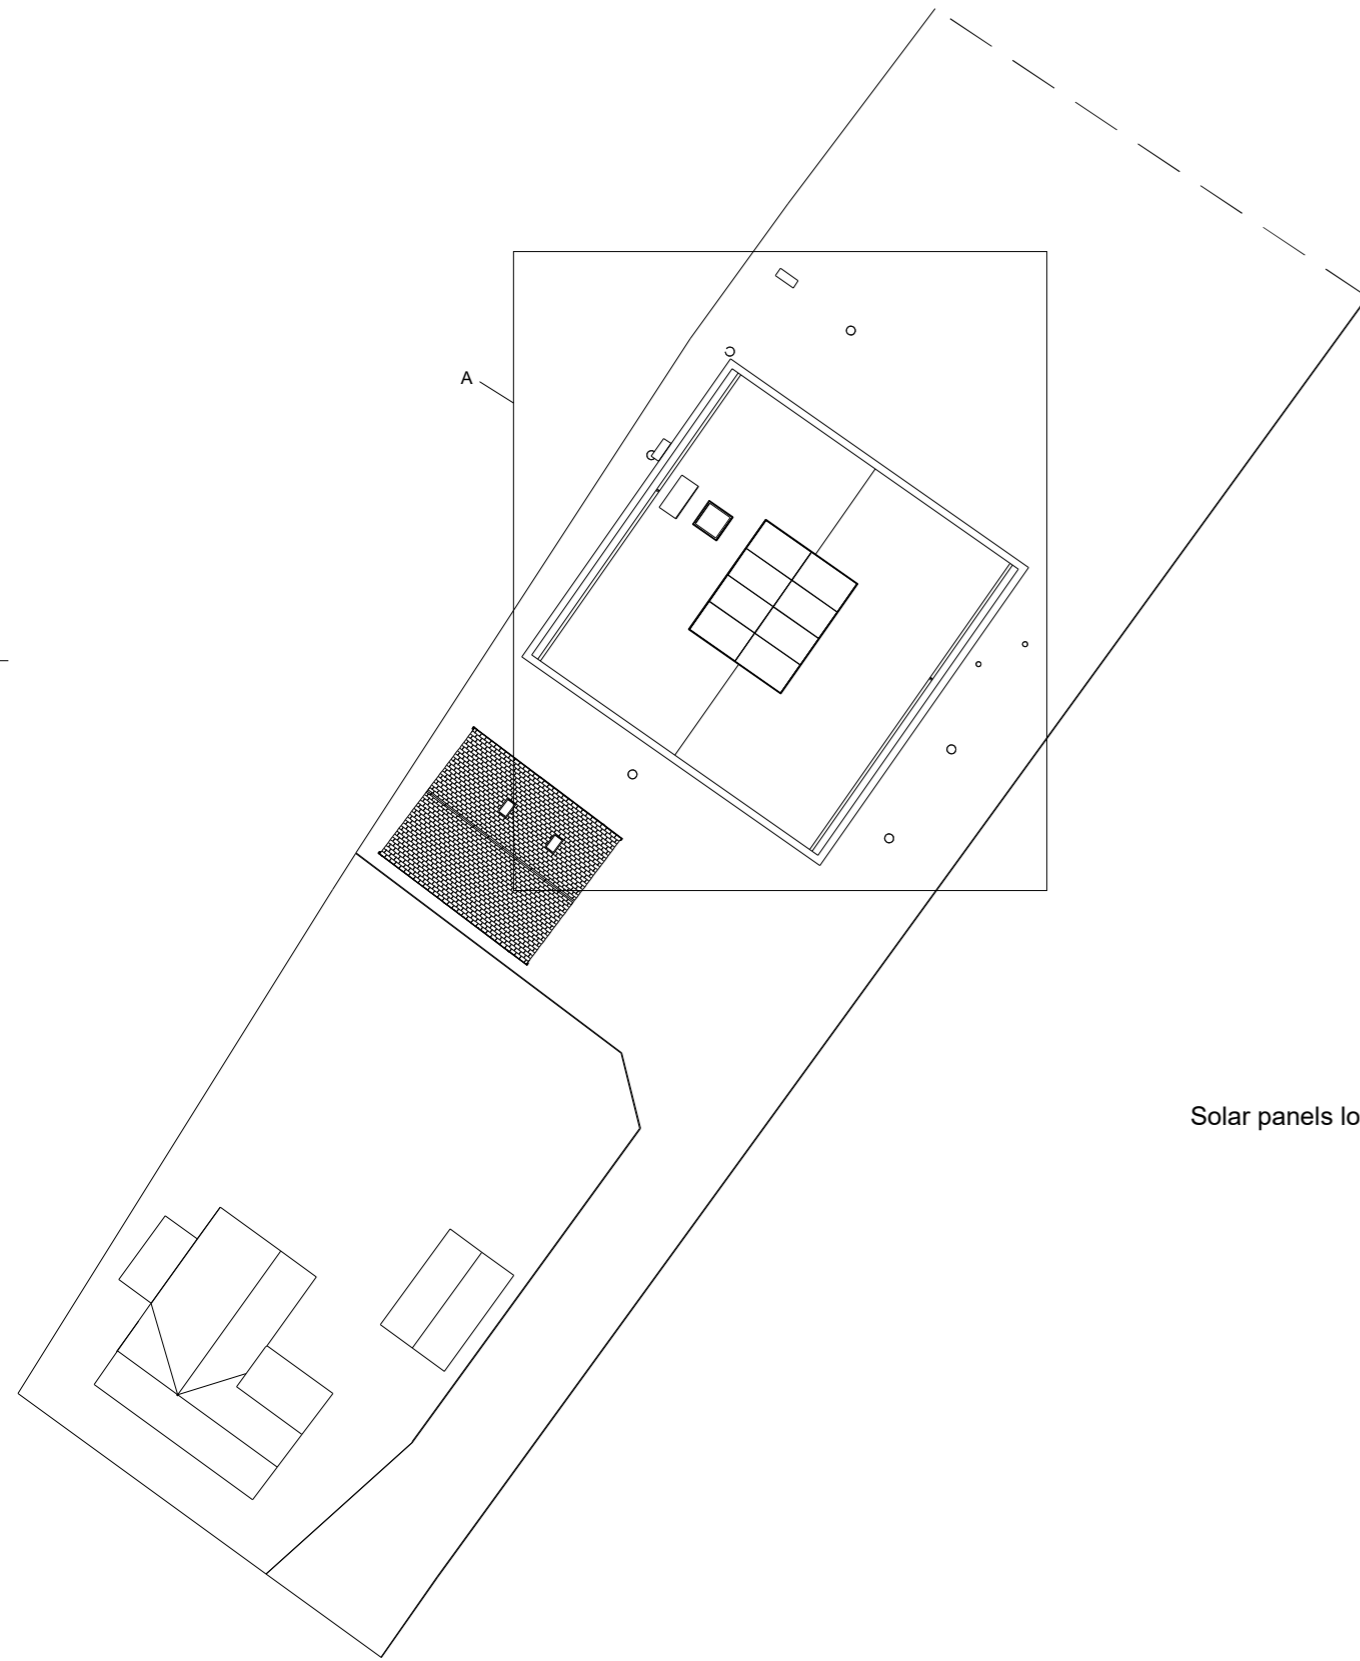

SCALE 1:200

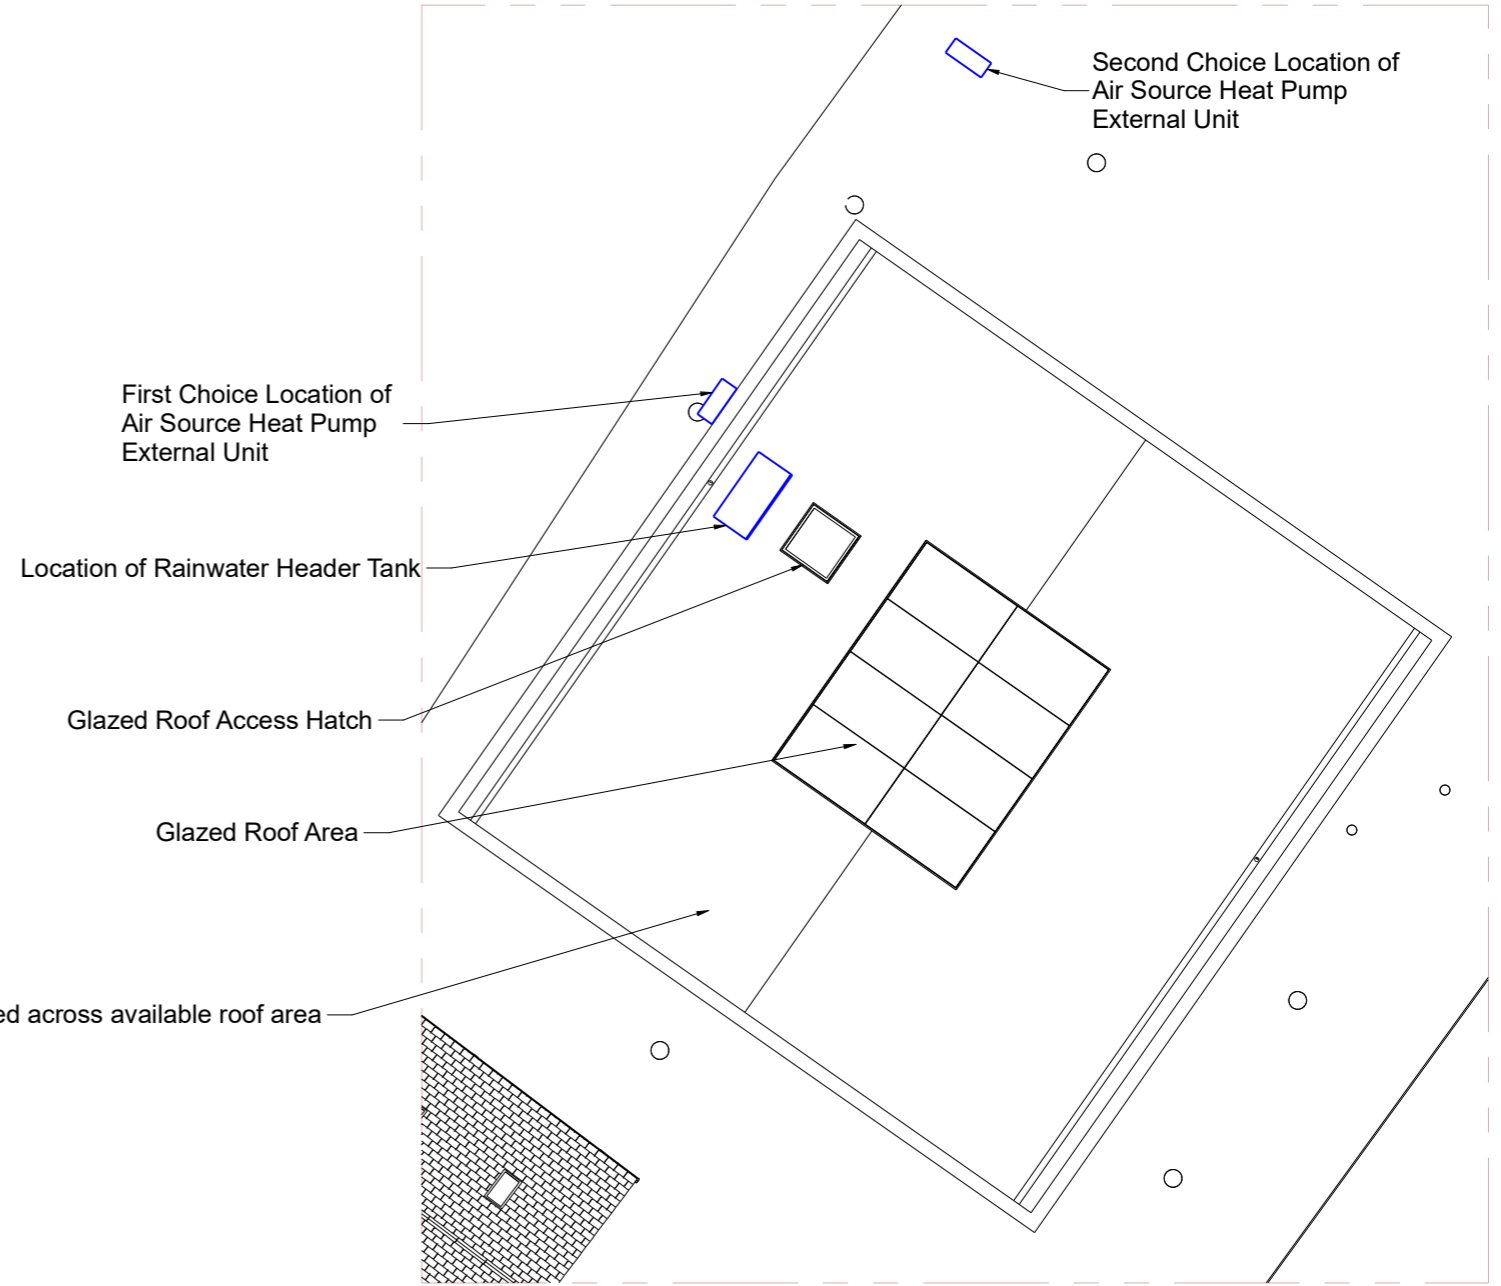

Detail A  
 SCALE 1:100

Revision History			Units:mm	Third Angle Projection	Rev No.:	Date:	Title:
Rev No.	Date	Changes	Scale: @ A1	☐	1A	16/10/2021	Roof Plan and Heat Pump location
1A	16/10/2021	New Drawing	Sheet: 1 of 1	A1	Drawn: JES	Checked: <chik>	Drawing Number: H100-RP-01
					Revision note: New Drawing		